



1 FLOOR PLAN - DOMESTIC WATER
SCALE: 3/8" = 1'-0"

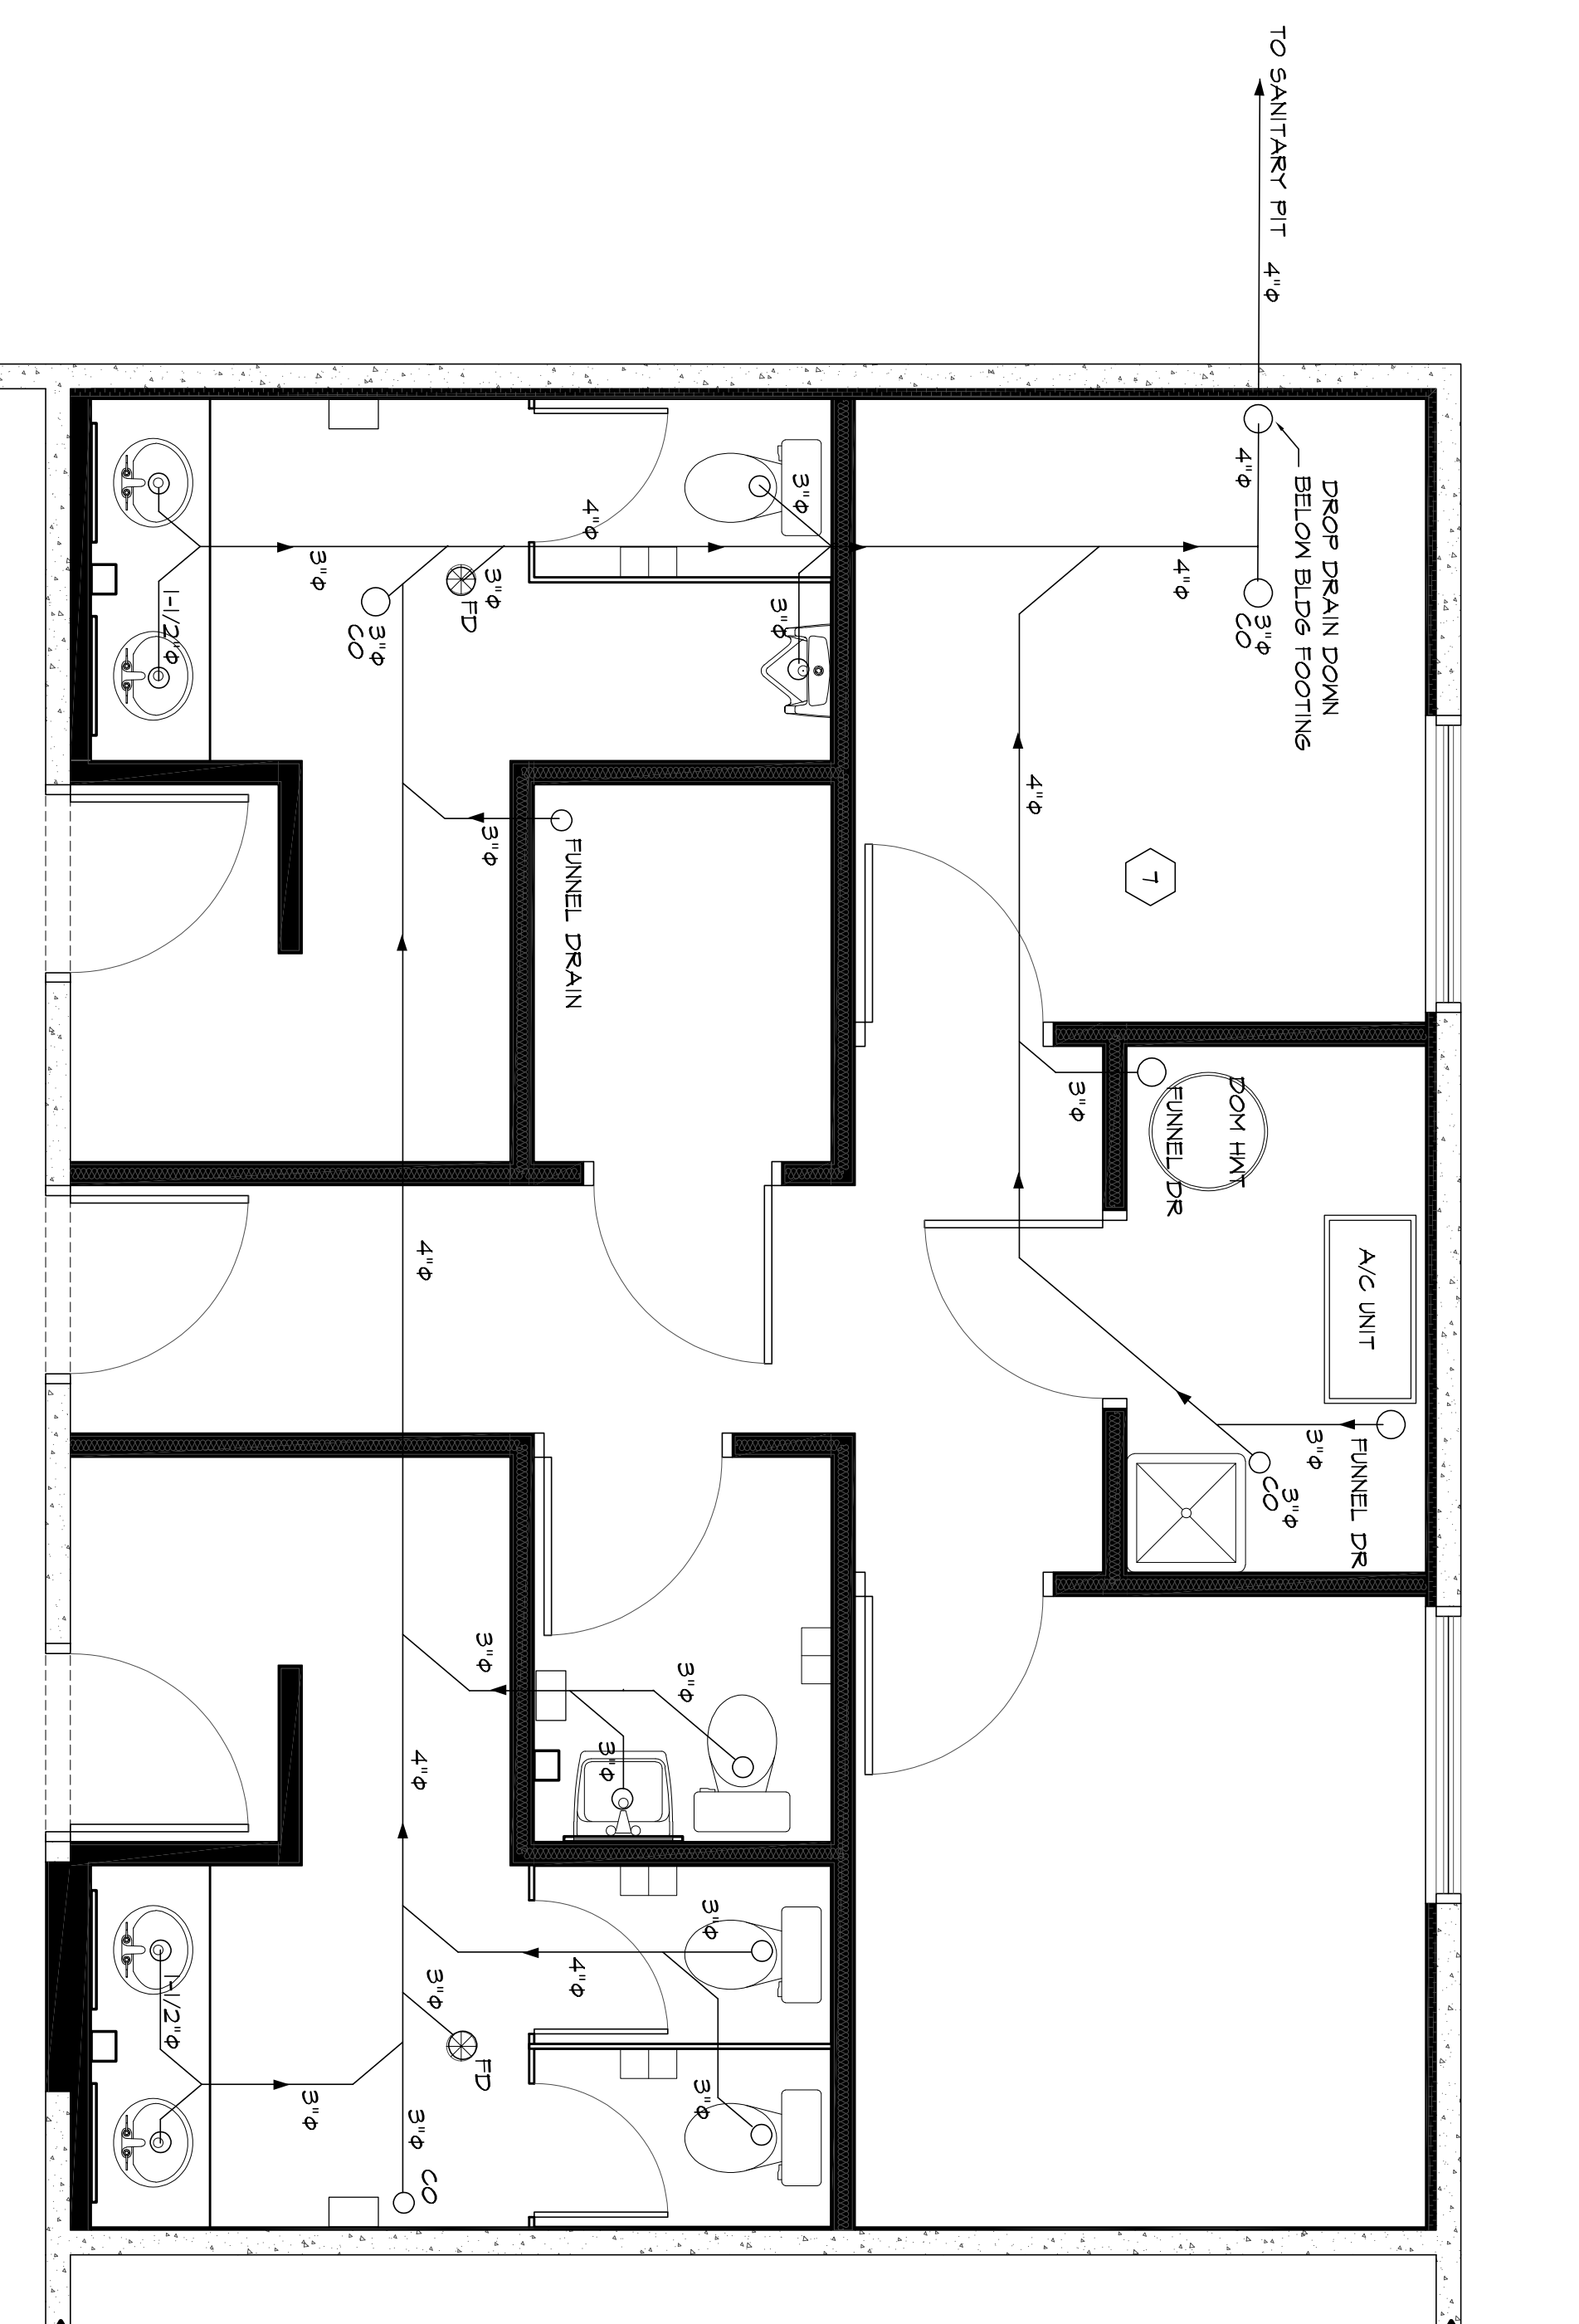


2 FLOOR PLAN - SANITARY PIPING
SCALE: 3/8" = 1'-0"

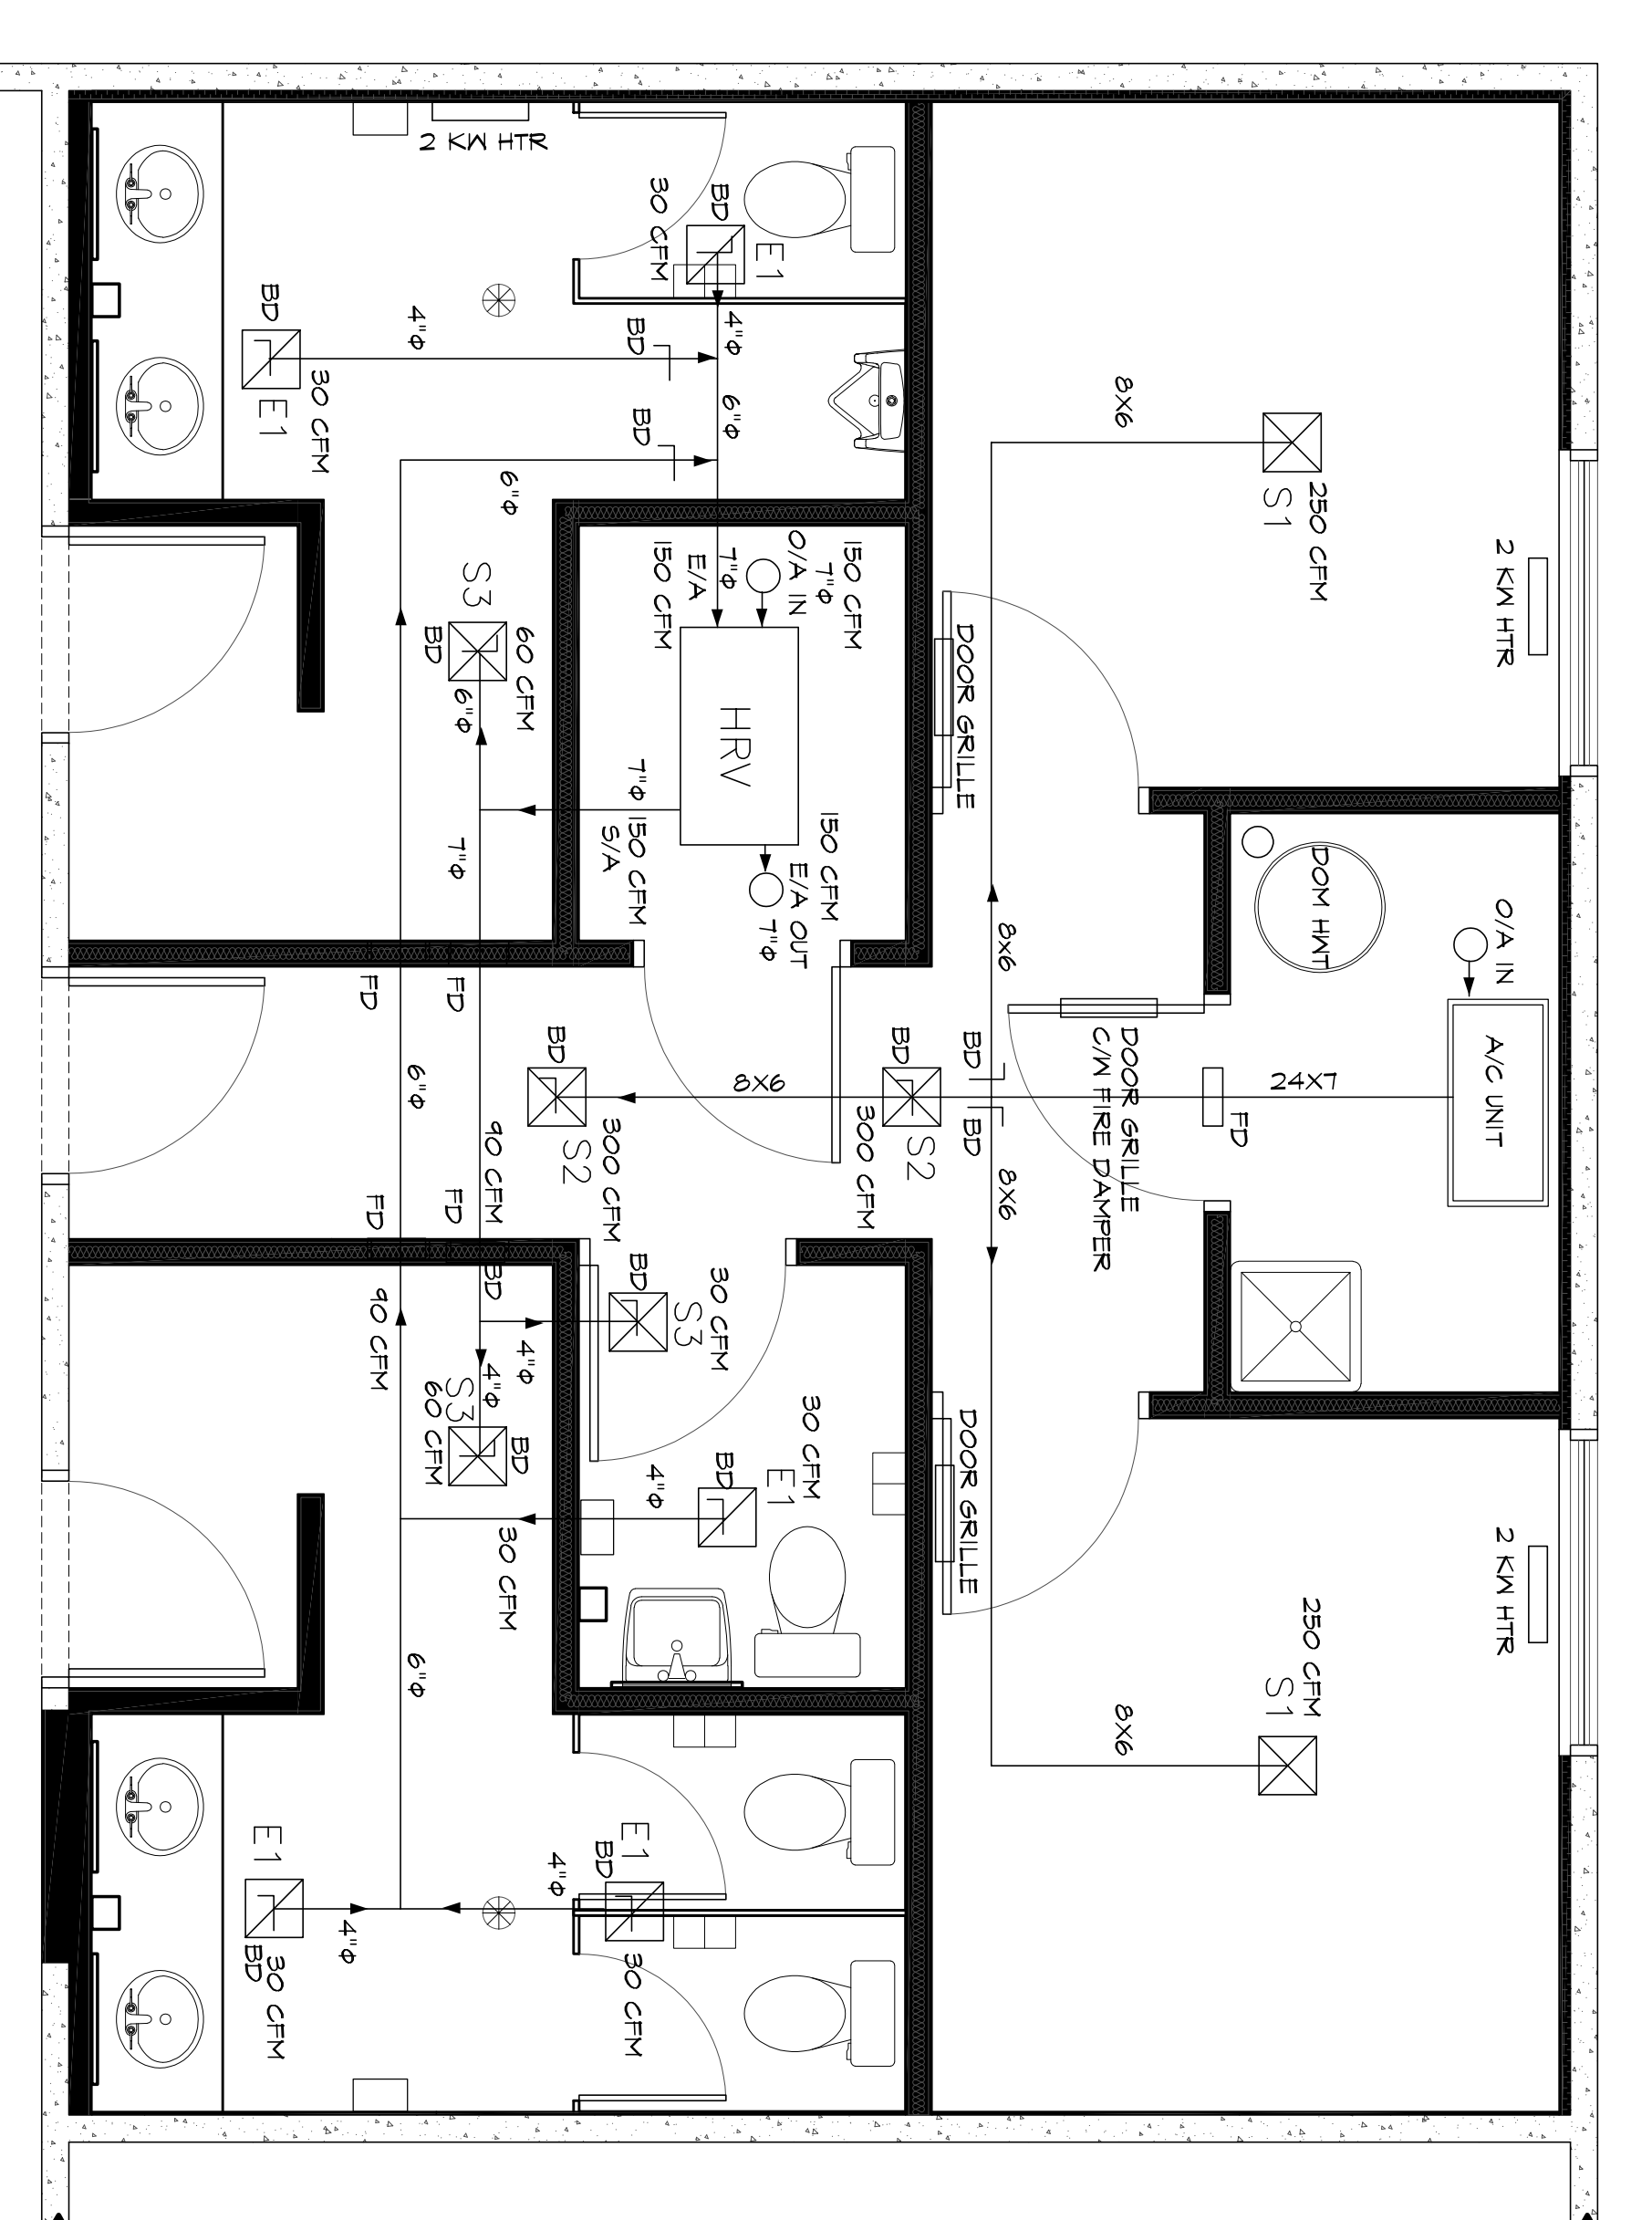


3 FLOOR PLAN - HVAC SYSTEMS
SCALE: 3/8" = 1'-0"

PLUMBING LINE/TYPE DESIGNATION


---	DOM. CWS	DOMESTIC COLD WATER
---	DOM. HWS	DOMESTIC HOT WATER SUPPLY
---	SAN	SANITARY DRAINAGE PIPING

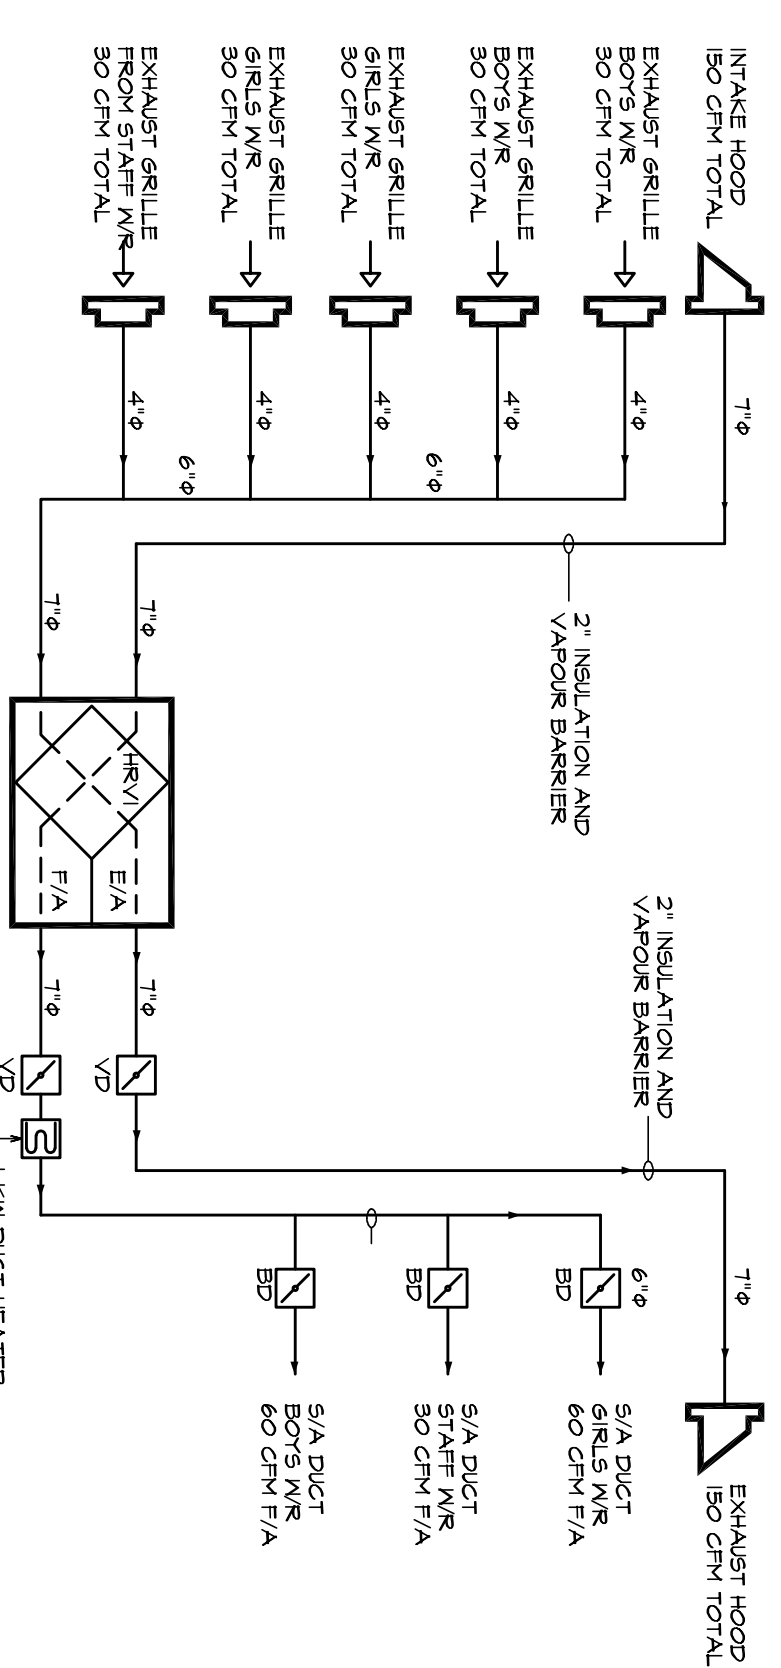

4 HRV SCHEMATIC DETAIL
SCALE: NTS

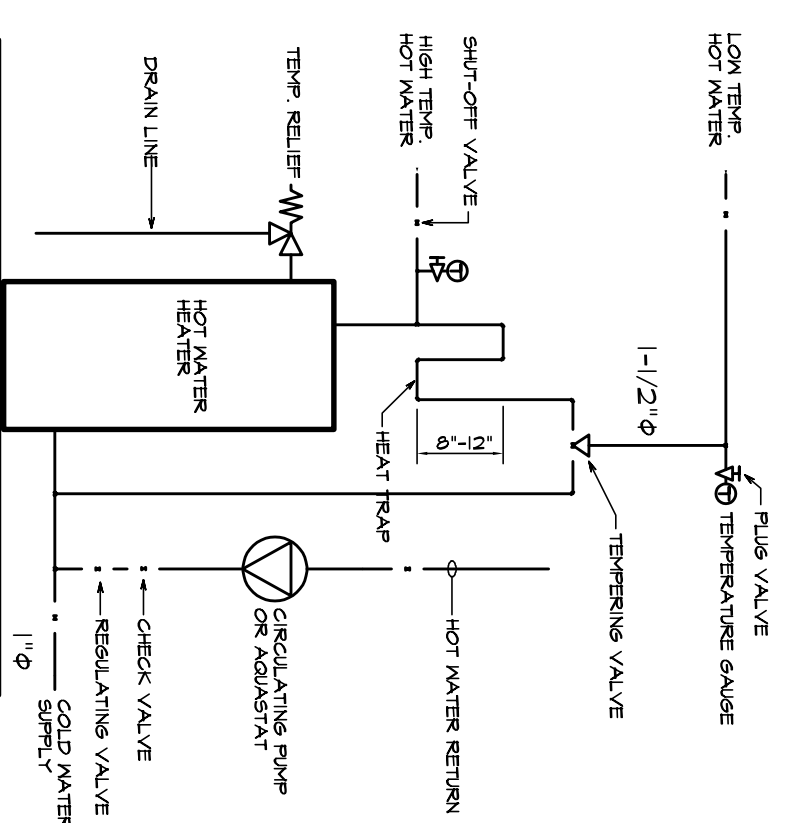


5 HM TANK PIPING
SCALE: 3/8" = 1'-0"

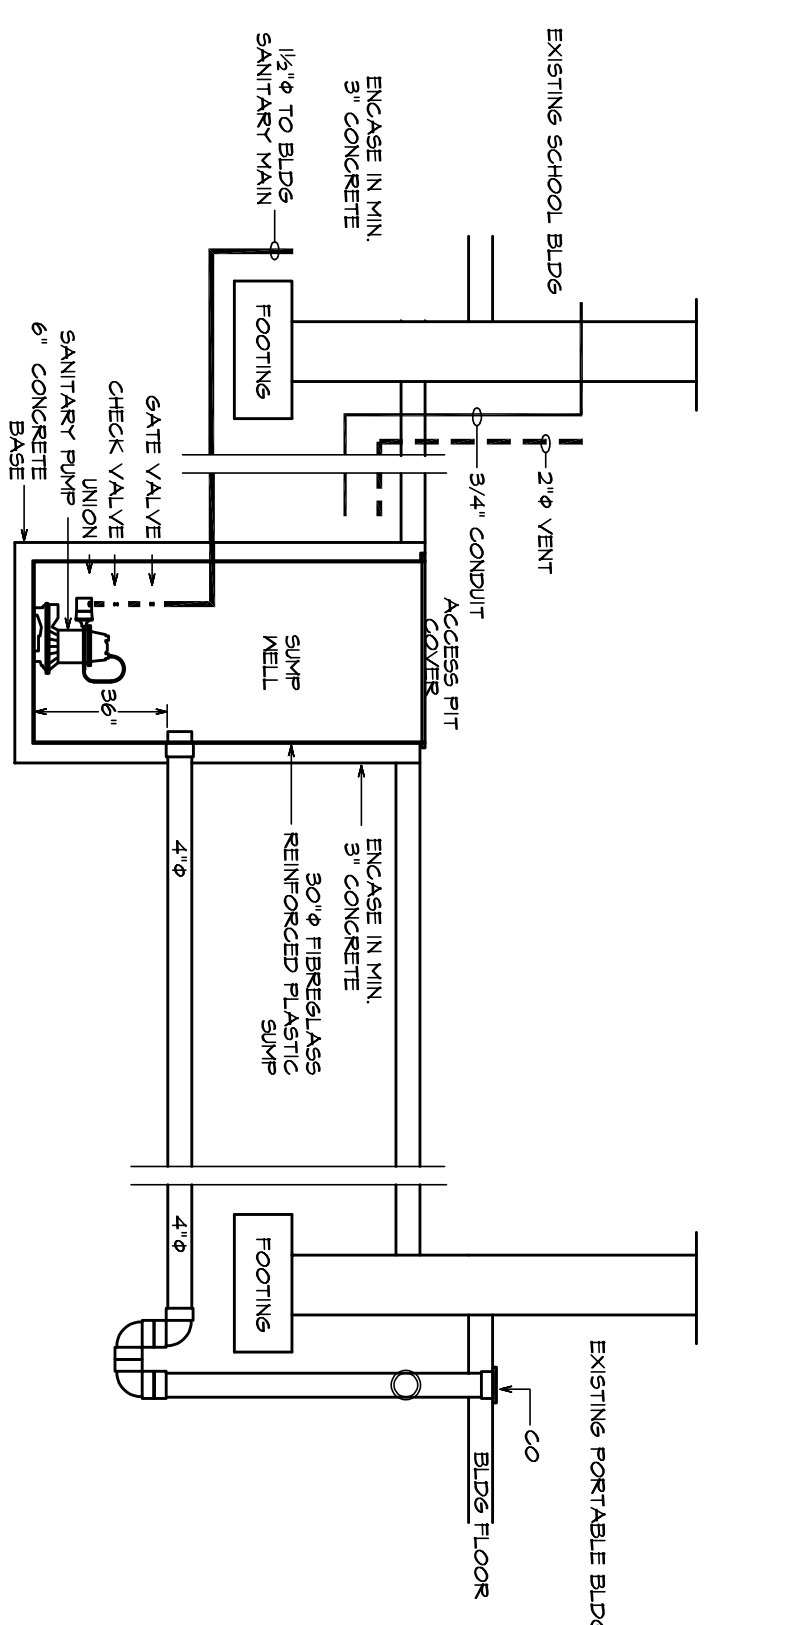

6 SANITARY PIPING DETAIL
SCALE: 3/8" = 1'-0"

NO.	DESCRIPTION	DATE	BY
0	ISSUED FOR REVIEW	05/15/23	GF5

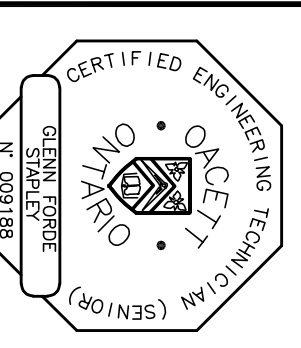

THIS DRAWING IS AN INSTRUMENT OF PROFESSIONAL SERVICE FOR USE EXCLUSIVELY ON THIS PROJECT. PROHIBITED. COPYRIGHT 2013 © O'DAVARE TECHNICAL SERVICES LTD.

OTS ENGINEERING
224 King Street
Peterborough, Ont.
Phone: (705) 745-5530
Fax: (705) 745-7486
Email: info@otsengineering.com

**ST STEPHENS SCHOOL
PORTABLE UPGRADES
MECHANICAL SERVICES
LINDSAY ONTARIO**

MECHANICAL SERVICES

SCALE	AS NOTED	DWG NO.	M1
DESIGNED	GF5	REV. 0	MAY 12
CHECKED	GF5	CADD FILE NO.	23011-A
PROJECT	23011-A		